


2 - COURT LIGHTING LAYOUT

BURIED ELECTRICAL CABLES 800 MIN.
FLOODLIGHTS ON DIRECT BURIED CONCRETE POLES (TYP.)

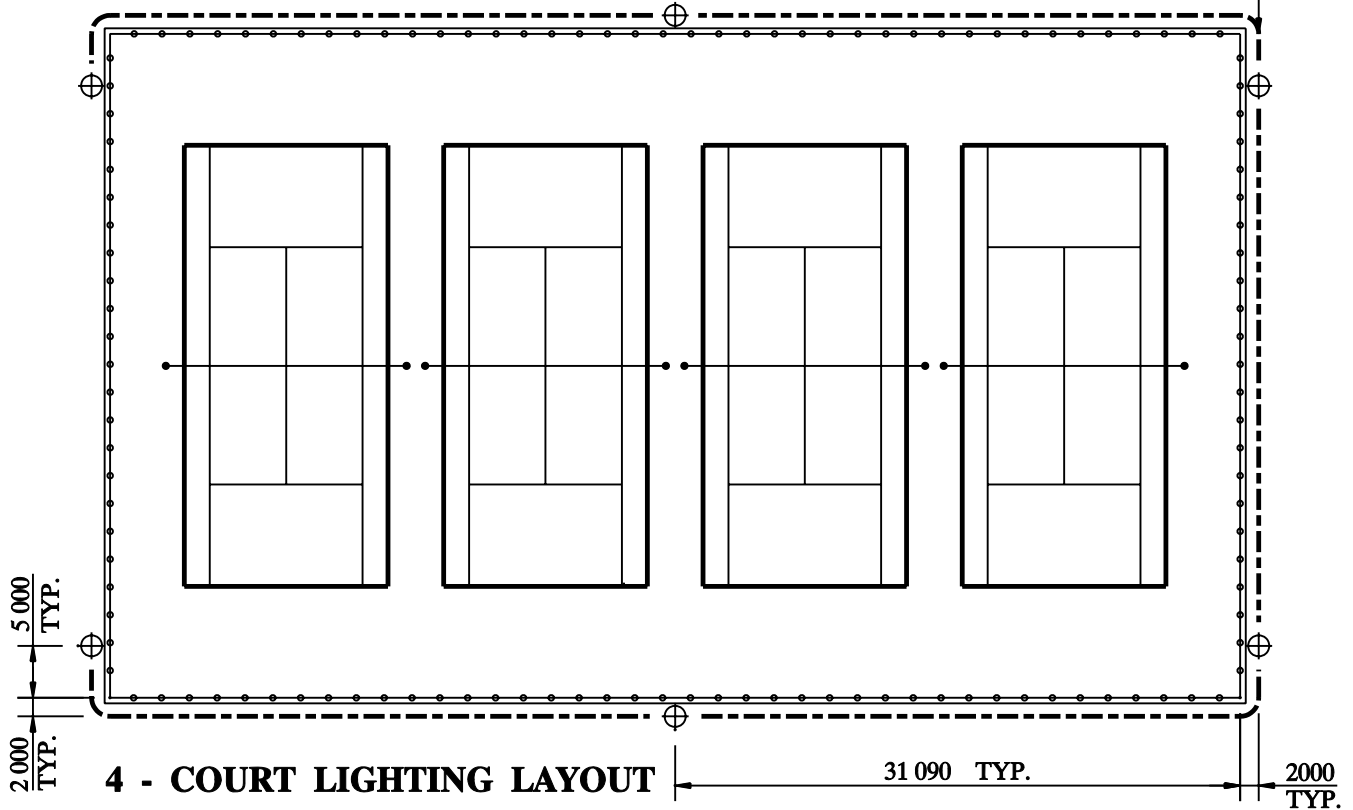

NOTES:

1. NO SWALES, BERMS CATCH BASINS, OR PLANTING WITHIN 6 000 OF POLES
2. GRADE WITHIN 6000 OF POLES; NOT TO EXCEED 5% SLOPE FOR VEHICULAR ACCESS
3. ALL MEASUREMENTS ARE IN MILLIMETRES UNLESS STATED OTHERWISE



**PLANNING,
DESIGN &
DEVELOPMENT
DEPARTMENT**

TITLE:
**TENNIS COURT LIGHTING
(2 and 4 Courts-in-battery Layout)**

DRAWING NO.
PDD 483

REVIEWED BY: *SH*

SCALE: N.T.S.

APPROVED BY: *John Wald*

DATE: JANUARY 2007